




LEGEND:

- W — WATER MAIN
- D — STORM DRAIN
- S — SANITARY SEWER
- ⊖ WATER METER
- BOULEVARD WATER SERVICE

ADDRESS: _____
 LOT: _____
 BLOCK: _____
 PLAN: _____
 ZONING: _____
 LAND USE: _____

UNDERGROUND SERVICE INFORMATION

INFORMATION IS AT PROPERTY LINE	STORM DRAIN	SANITARY SEWER
PROPOSED DEPTH (m)		
PROPOSED INVERT ELEVATION (m)		
MAXIMUM DEPTH REQUESTED	<input type="checkbox"/> YES <input type="checkbox"/> NO	<input type="checkbox"/> YES <input type="checkbox"/> NO

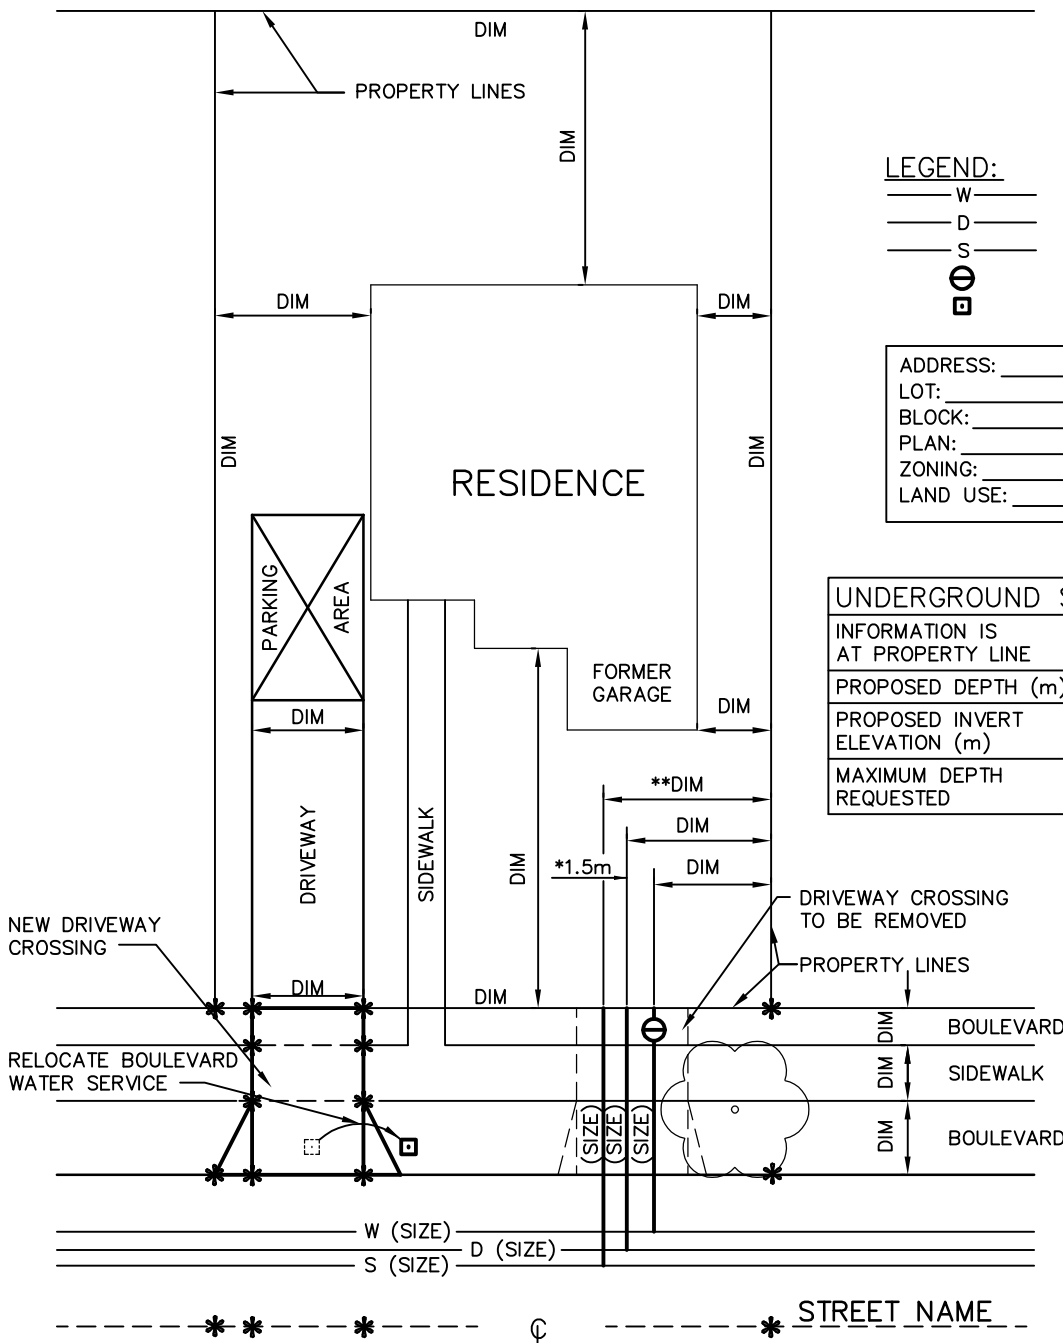


SITE SERVICING PLAN – TYPE B

SCALE :

NOTES:

1. DIMENSIONS (DIM) ARE TO BE SHOWN IN METRES.
2. SHOW PARKING LOCATION AND DIMENSIONS IN ACCORDANCE WITH SCHEDULE 'C' OF THE ZONING BYLAWS.
3. SHOW NEW DRIVEWAY CROSSING IN ACCORDANCE TO HIGHWAY ACCESS BYLAW 91-38.
- *4. THE WATER SERVICE CONNECTION SHALL, PREFERABLY BE 1.5m FROM THE OTHER SERVICE CONNECTIONS. ALTERNATIVE LOCATIONS MUST BE APPROVED BY THE CITY ENGINEER.
- **5. SANITARY SEWER AND STORM DRAIN SERVICE CONNECTORS TO BE INSTALLED IN COMMON TRENCH UNLESS OTHERWISE APPROVED BY THE CITY ENGINEER. (REFER TO PLUMBING BYLAW 82-44, SECTION 34).
6. * SPOT ELEVATION EXISTING / [PROPOSED]

SITE PLAN TO ACCOMPANY BUILDING PERMIT APPLICATION FOR _____ (ADDRESS)

DATE	REVISION DESCRIPTION	APP'D
CORPORATION OF THE CITY OF VICTORIA		
		
TITLE SITE SERVICING PLAN – TYPE B		
ENGINEERING DEPARTMENT		
SCALE NTS	SHT. NO. 1 OF 1	
DATE 08/09/09	DRAWING NUMBER STD105	
APP'D BY D.O.		